




GATE VALVE INDICATOR POST
SCALE 1:5

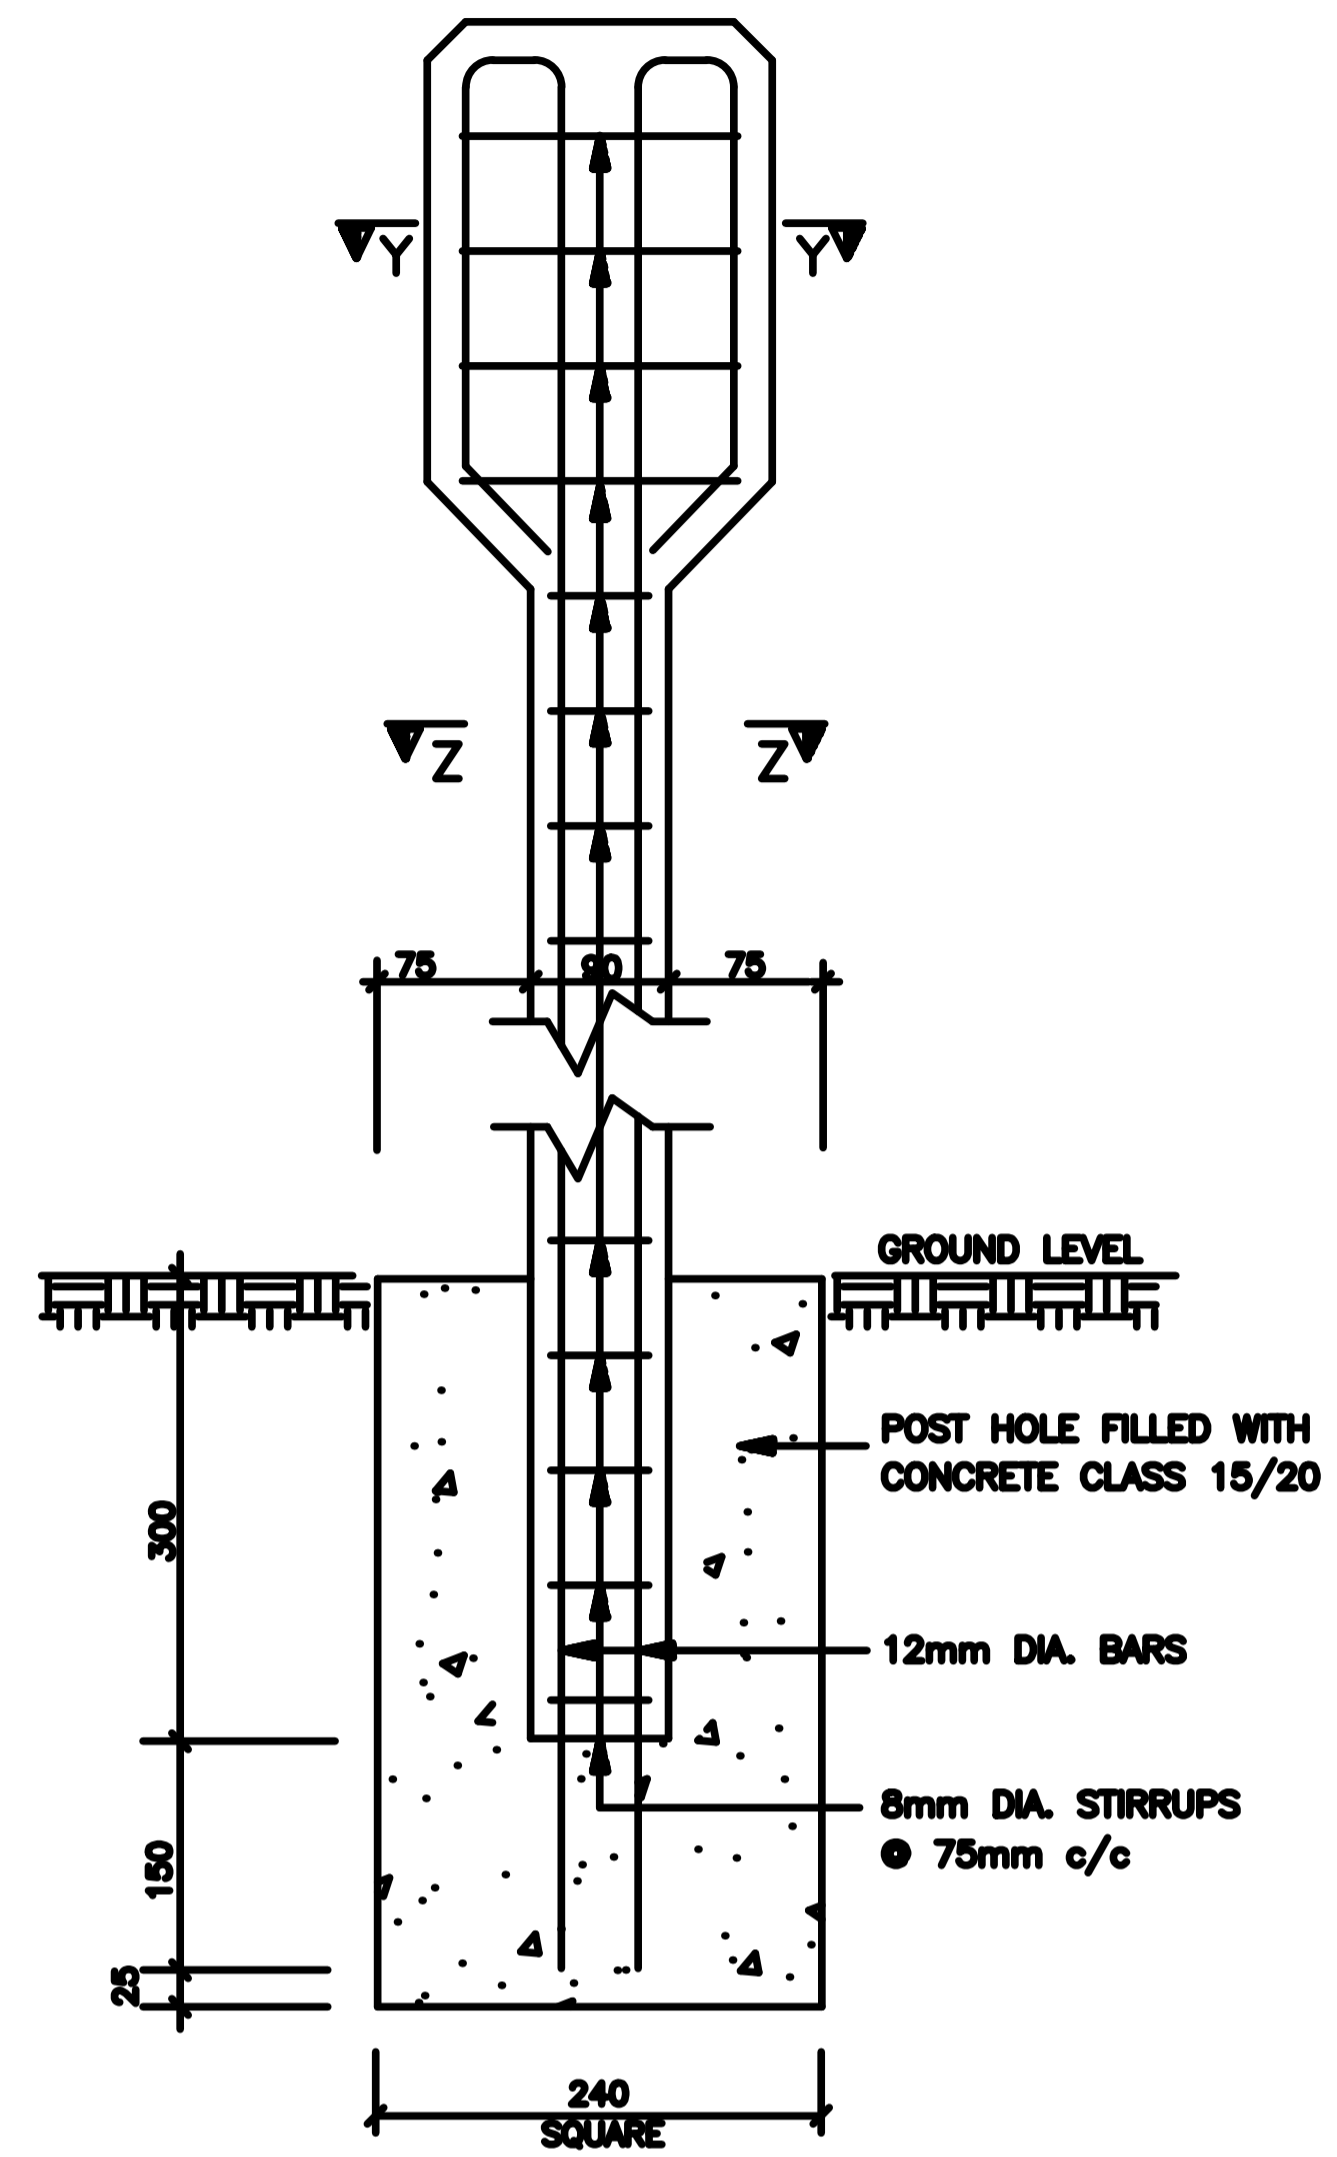


INDICATOR POST REINFORCEMENT DETAILS
SCALE 1:5

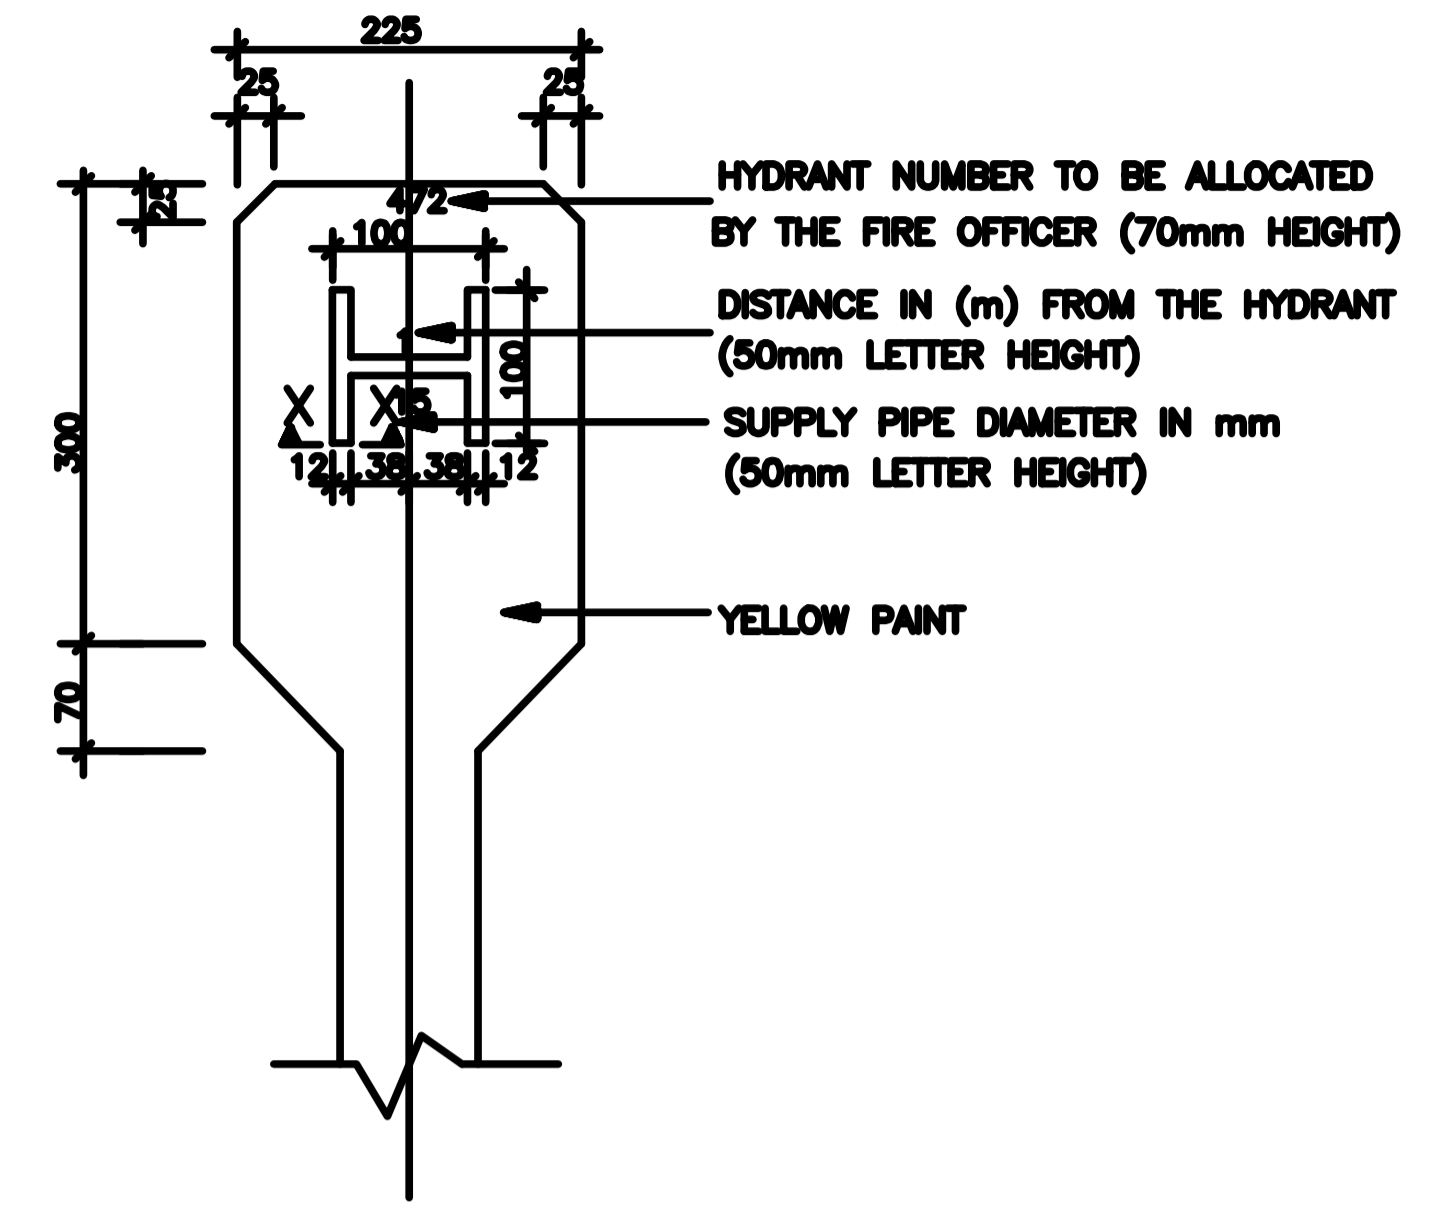


FIRE HYDRANT POST
SCALE 1:5

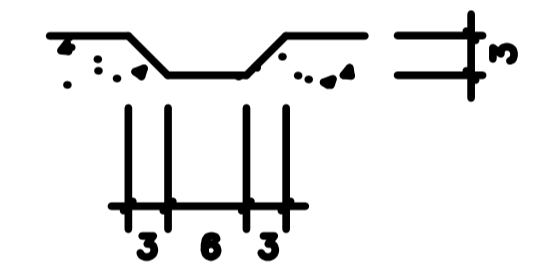

SECTION X-X
SCALE 1:5

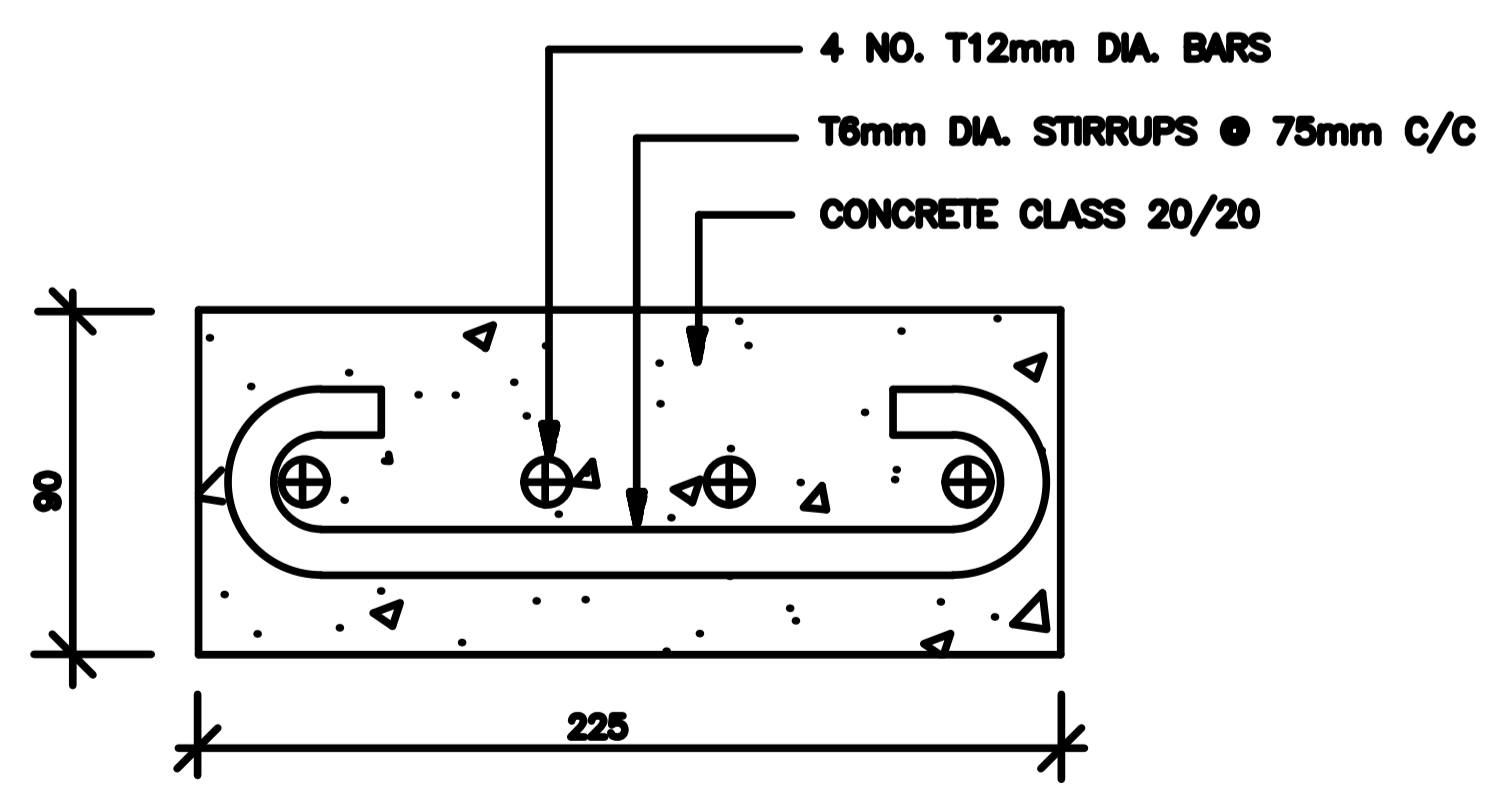

SECTION Y-Y
SCALE 1:5

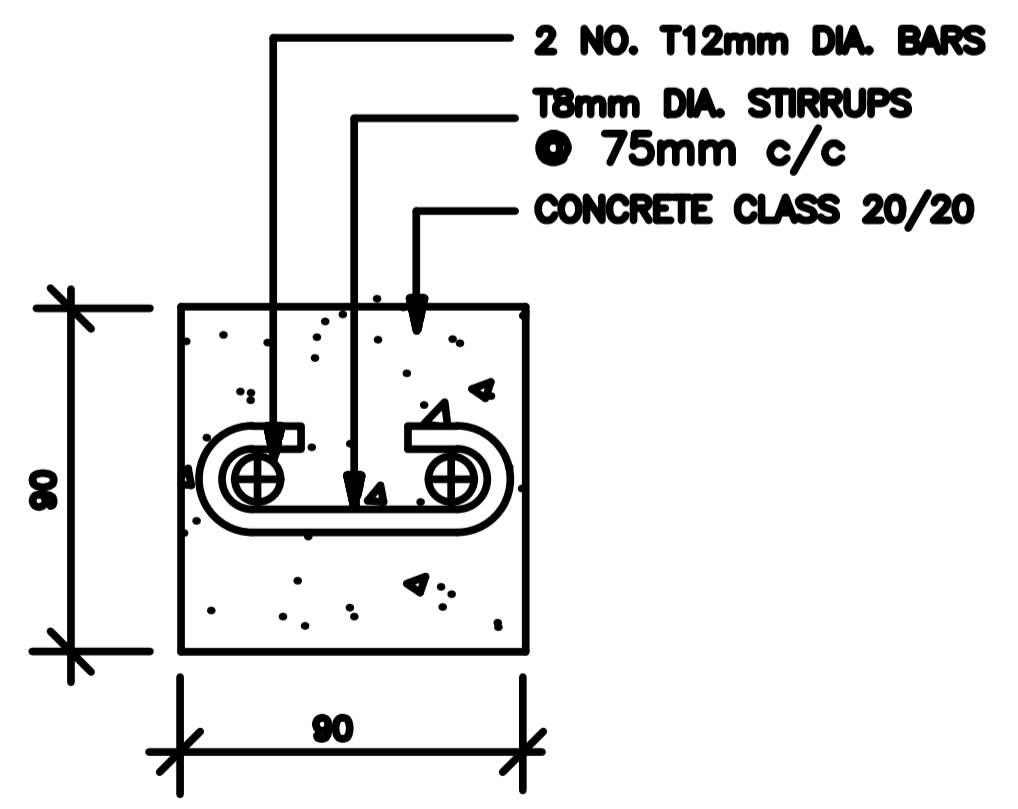

SECTION Z-Z
SCALE 1:5


NOTES

- ALL DIMENSIONS ARE IN mm UNLESS OTHERWISE STATED.
- DETAILS FOR INDICATOR POSTS TO BE AS FOR GATE VALVE BUT LETTERING TO BE AS FOLLOWS:

FOR	USE
GATE VALVE	GV
AIR VALVE	AV
WASHOUT	WO
STRAINER	ST
WATER MAIN	WM
BULK METER	M
SLUICE VALVE	SV
- ALL INDICATOR POSTS TO BE PAINTED WITH 2 COATS OF BLUE OIL BASED PAINT AND LETTERING TO ENGINEER'S APPROVAL.
- MAKER POSTS TO BE POSITIONED IN SAFE LOCATIONS WHERE POSSIBLE AGAINST BOUNDARY OF ROAD RESERVE

C		BY	
		CHECKED	
B		BY	
		CHECKED	
A		BY	
		CHECKED	
O		BY	
		CHECKED	

REV R E V I S I O N S Drg. No.:

CLIENT:

MATHRA WATER AND SANITATION COMPANY LTD.
P.O. BOX 1887 - WARD KARANJA, NYERI

PROJECT:
IMPROVEMENT OF WATER SUPPLY TO WIRIMUNGU WARD MATHRA WEST SUB-COUNTY

KIAMUCHERU_MUBERETHI RAW WATER GRAVITY MAINLINE

Designed by: MAWASCO Drawn by: ---
Checked by: --- Approved by: ---

TITLE:
MARKER POST DETAILS

Scale	AS SHOWN	Date:	OCTOBER 2023
Job No.		CAD FILE No.	
T STATUS	DRAWING No. MAWASCO/KM/03	REV	